


UNDERSINK
WATER
HEATER

VENT

CLEAN OUT

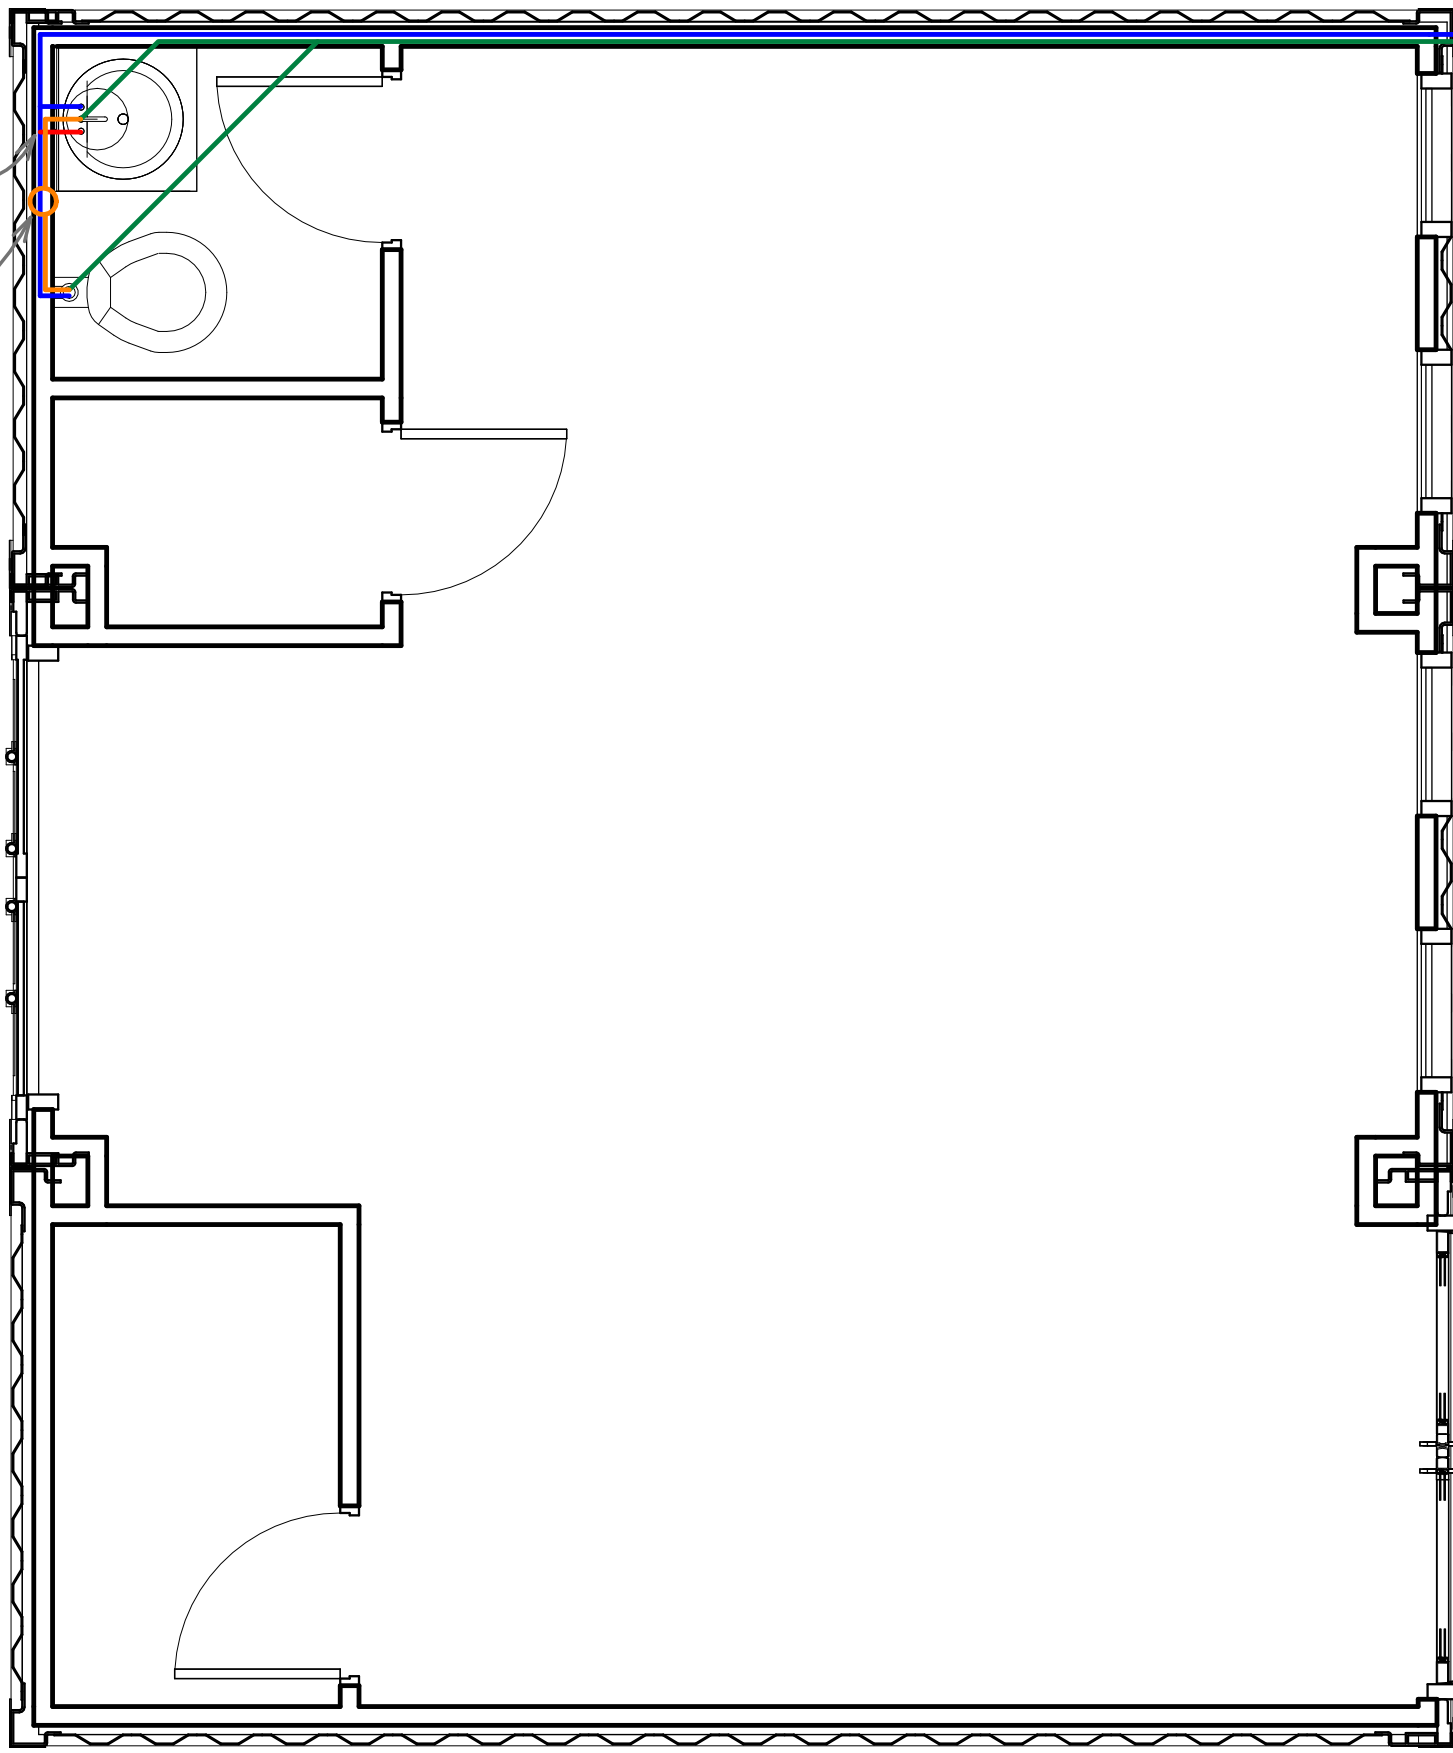

Scale: 3/8" = 1'-0"

Project:

Rest and Ride

View:

Plumbing Plan

Drawn By:

Jack DeBaugh